


SITE PLAN
Scale, 1:2000

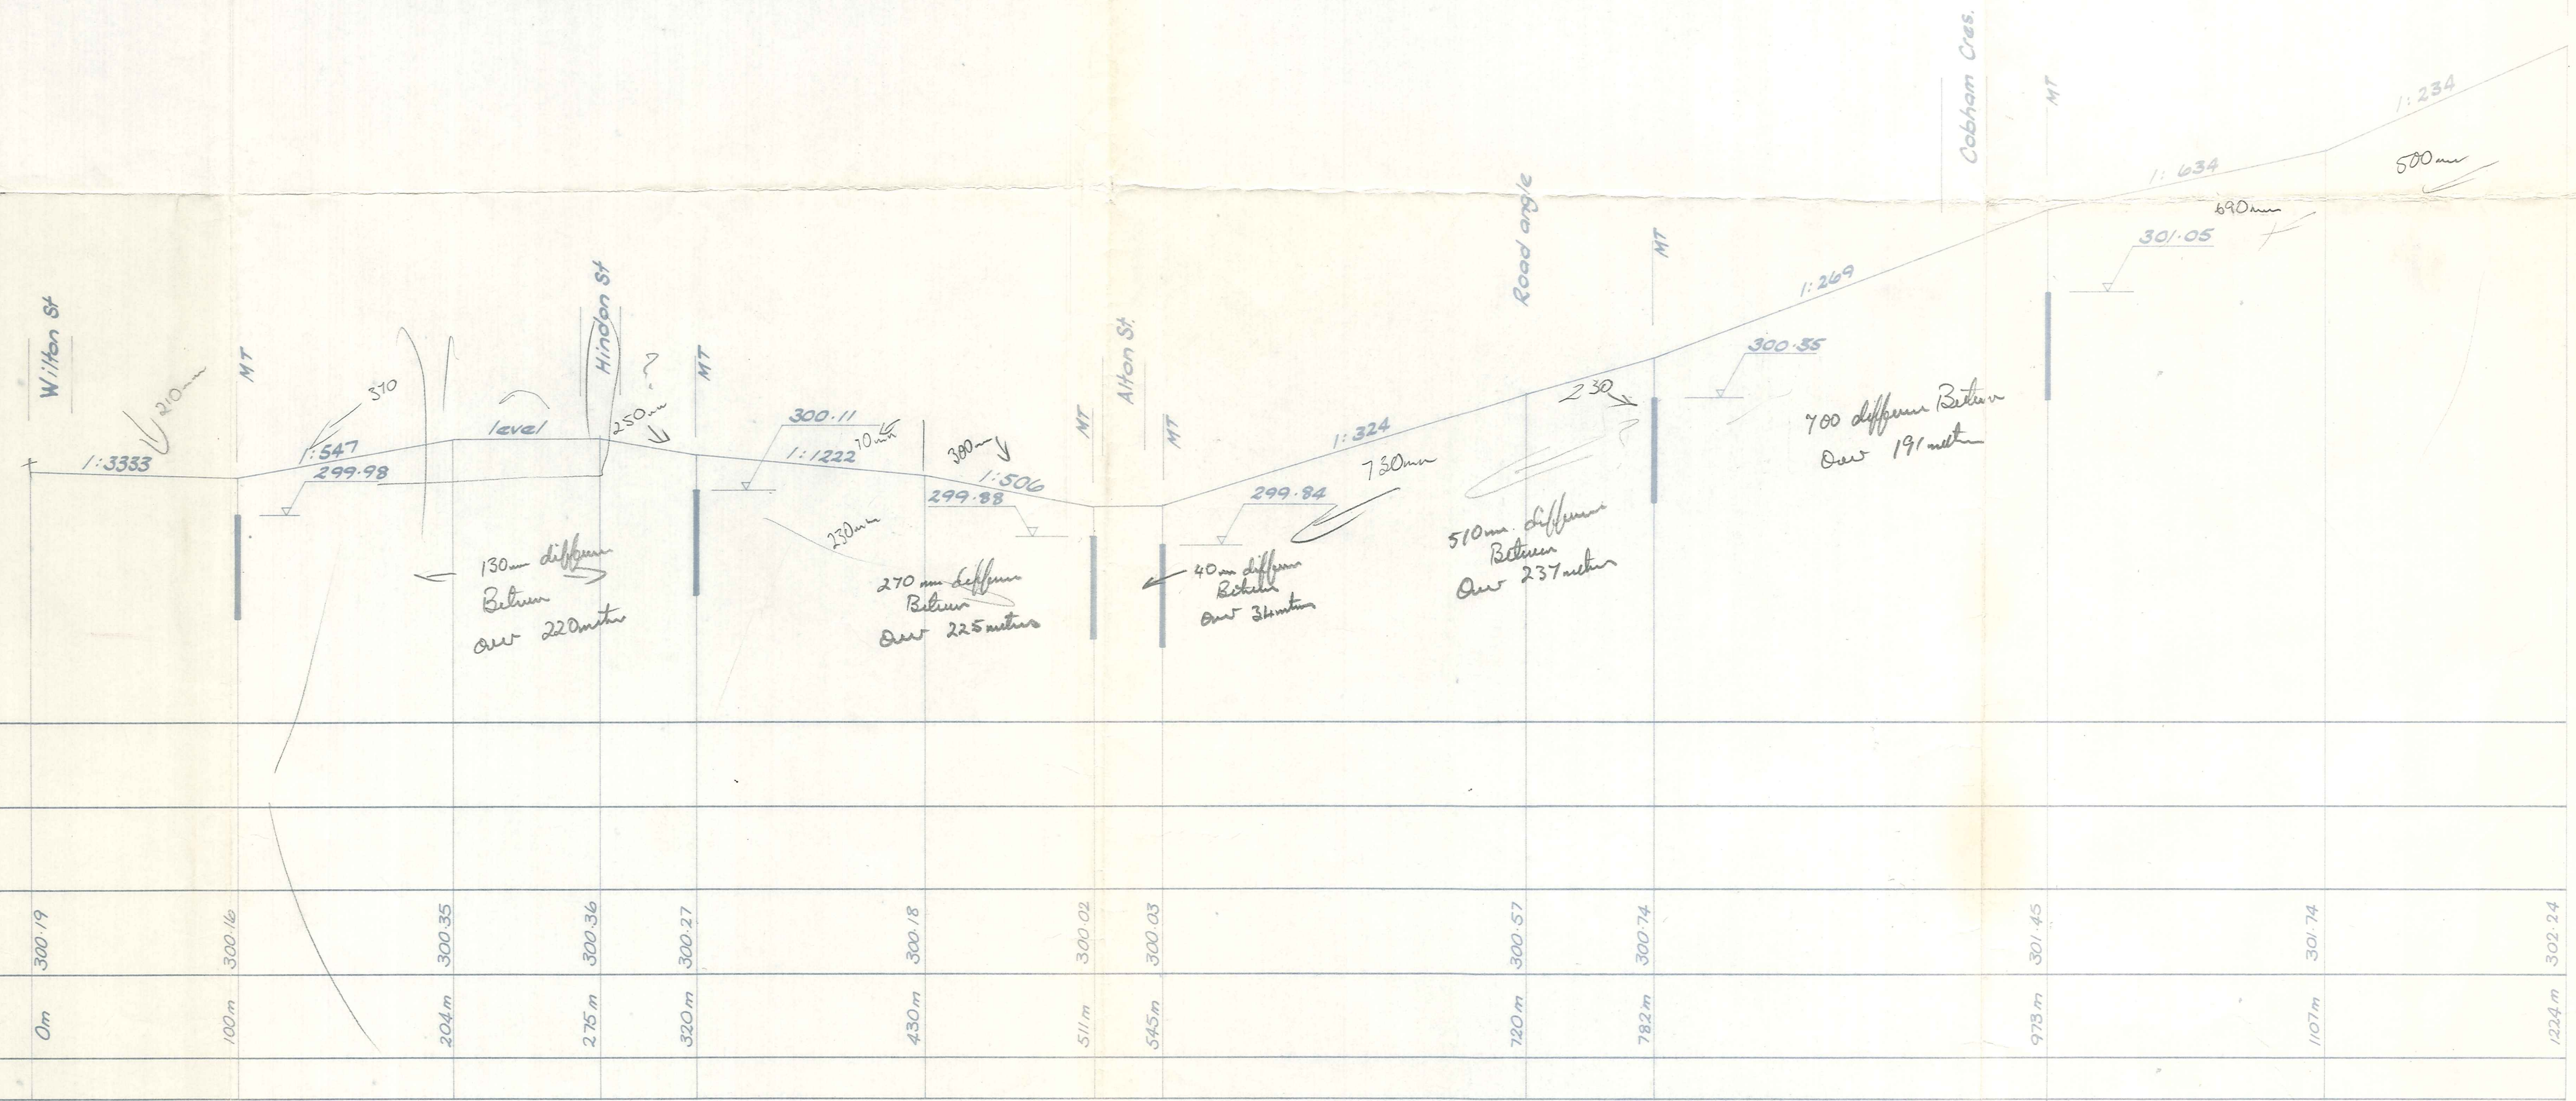

LONG SECTION ON LEASK ST. Scale; Horiz. 1:200 Vert. 1:20

DUFFILL WATTS & KING LTD
CONSULTING CIVIL & STRUCTURAL ENGINEERS
Dunedin P.O.Box 5269 Ph 777-133 Invercargill P.O.Box 576 Ph 83-049
Balclutha P.O.Box 220 Ph 81-664 Cromwell P.O.Box 82 Ph 50-391

VINCENT
COUNTY COUNCIL

STATE HIGHWAY DRAINAGE - OMAKAU

AMENDMENTS			NAME	DATE	JOB NO.	Sheet No
NO.	BY	DATE				
			GR Duff	Aug. 80	7971	1
						of 1 sheets
			OUTYSSON	Aug. 80	File 156	L.B. 92
						F.B.